


02 Tanker Routing
100 SCALE 1:500

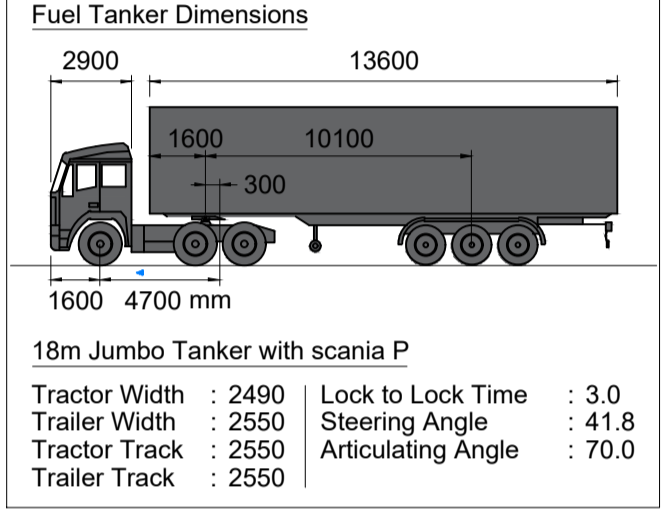

Equipment Legend	
Description	Graphic
Multi Product Dispenser (Diesel to be positioned closest to column)	
Fuel Fillers & Product tagging	
Sleeve Break	
Chubb "Everyway" Ø590mm Fire Hose Reel complete including 30m Hose.	
9kg DCP (ABC Multipurpose Type) Fire Extinguisher.	
Monitoring wells	MW
Tanker earthing	
Vapour recovery containment sump	
Air supply manifold	

Area Schedule	
Site Area	4497.6m²
Canopy containment slab	230m²
Sales Building	280m²
Carwash	40m²
Fast Food	257m²
Total	807m²
Coverage	18%

01 Site Plan
100 SCALE 1:200

NO	DATE	REVISION DESCRIPTION	DRAWN
A	2019-04-01	ISSUED FOR COMMENT	WG

THIS DRAWING IS COPYRIGHT AND IS TO BE RETURNED ON COMPLETION OF THE CONTRACT. ALL DIMENSIONS TO BE CHECKED BY THE CONTRACTOR ON SITE. FIGURED DIMENSIONS TO BE TAKEN IN PREFERENCE TO SCALING THE DRAWING. ANY DISCREPANCIES OR VARIATION REQUIREMENTS NOTICED ON SITE TO BE REPORTED TO THE PROJECT MANAGERS.

DESIGN OFFICE: EPSOM DOWNS OFFICE
PARK - OPTIMUM HOUSE
FIRST FLOOR, 13 SLOANE STREET -
BRYANSTON, 2191
POSTAL ADDRESS: PO BOX 3418 -
CRAMERVILLE - 2060 JOHANNESBURG

Co. Reg. No.: 1993/02336/07
VAT No.: 4890142344

Tel: +27 11 463 0073
Fax: 087 234 5750

CLIENT **Astron Energy (Pty) Ltd**

PROJECT **Muizenburg New Service Station**

ADDRESS **Cnr ST George Street & Eastbourne Road, Muizenburg Western Cape**

DRAWING TITLE
**Option 1:
Site Layout, Tanker Route
Aerial Map
BUILDING CLASSIFICATION: B1**

	RESPONSIBLE PERSON	DATE
DESIGN	W. Geyer	2019-04-01
DRAWN	W. Geyer	2019-04-01
CHECKED	W. Batchelor	2019-04-01
PROJECT MANAGER		
CLIENT		

DRAWING NUMBER			
PROJECT IP No.	PHASE	DRAWING NUMBER	REVISION
MUIZ	- PRE -	100	- A

DRAWING PHASES:	SHEET SIZE
PRE = PRELIMINARY FEA = FEASIBILITY PER = PERMIT TEN = TENDER ENG = ENGINEERING ASB = AS BUILT	A0
	SCALE As Shown

SIGNATURE

DATE
SIGNATURE OF REGISTERED OWNER OF PROPERTY OR AUTHORISED REPRESENTATIVE

Owner

Draft Proposal

